

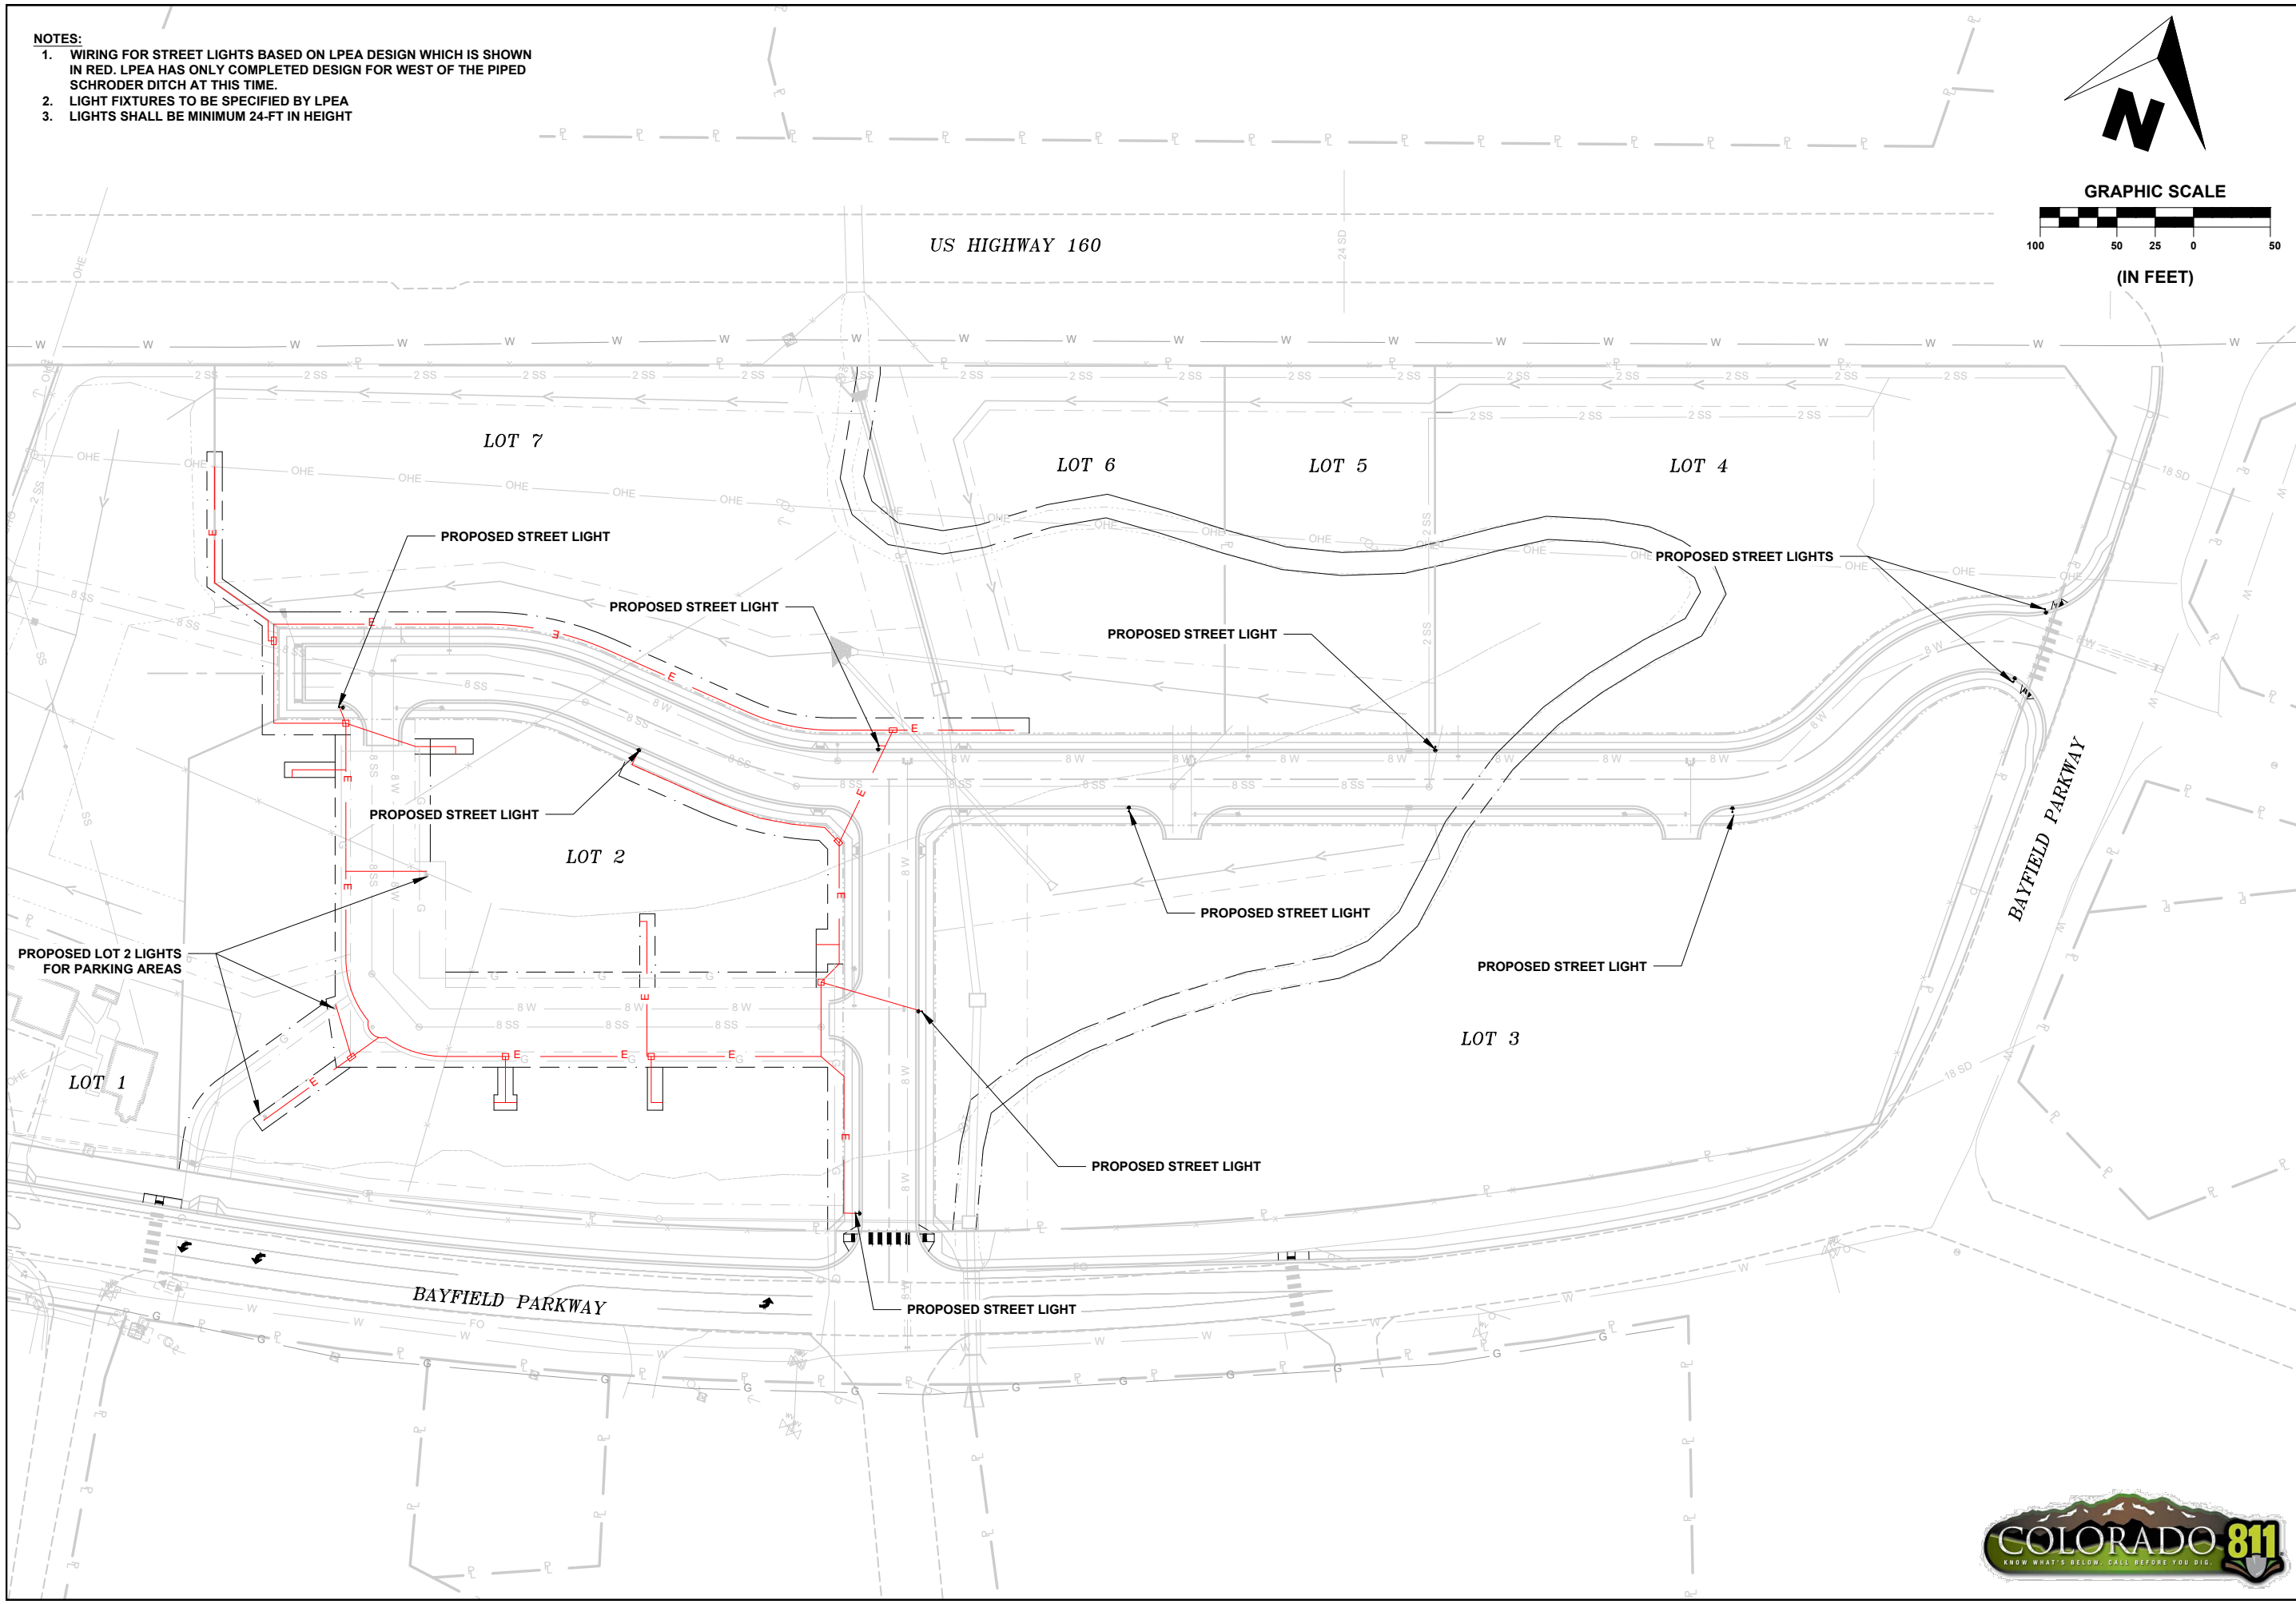
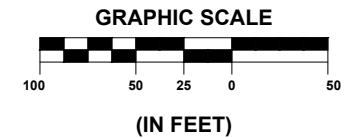


- NOTES:**
1. WIRING FOR STREET LIGHTS BASED ON LPEA DESIGN WHICH IS SHOWN IN RED. LPEA HAS ONLY COMPLETED DESIGN FOR WEST OF THE PIPED SCHRODER DITCH AT THIS TIME.
  2. LIGHT FIXTURES TO BE SPECIFIED BY LPEA
  3. LIGHTS SHALL BE MINIMUM 24-FT IN HEIGHT

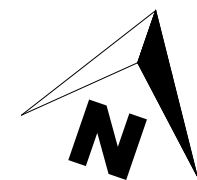

**SHEET**  
1 OF 1

**PST ENGINEERING, LLC**  
2615 MAIN AVE. SUITE 209  
DURANGO, CO 81301  
970-403-5492

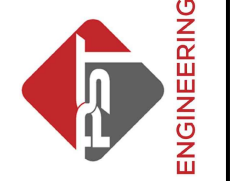

**HAGA PROPERTY  
MASTER PLAN  
2107 BAYFIELD PARKWAY  
BAYFIELD, CO 81122  
LIGHTING PLAN**

**REVISIONS:**

#	DATE	DESCRIPTION	SHEET

DATE: 9/14/2023  
DRAWN BY: HR  
CHECKED BY: SP



**FINAL**